




ONYX

FLOOR PLAN I  
SCALE: 1:80 cm



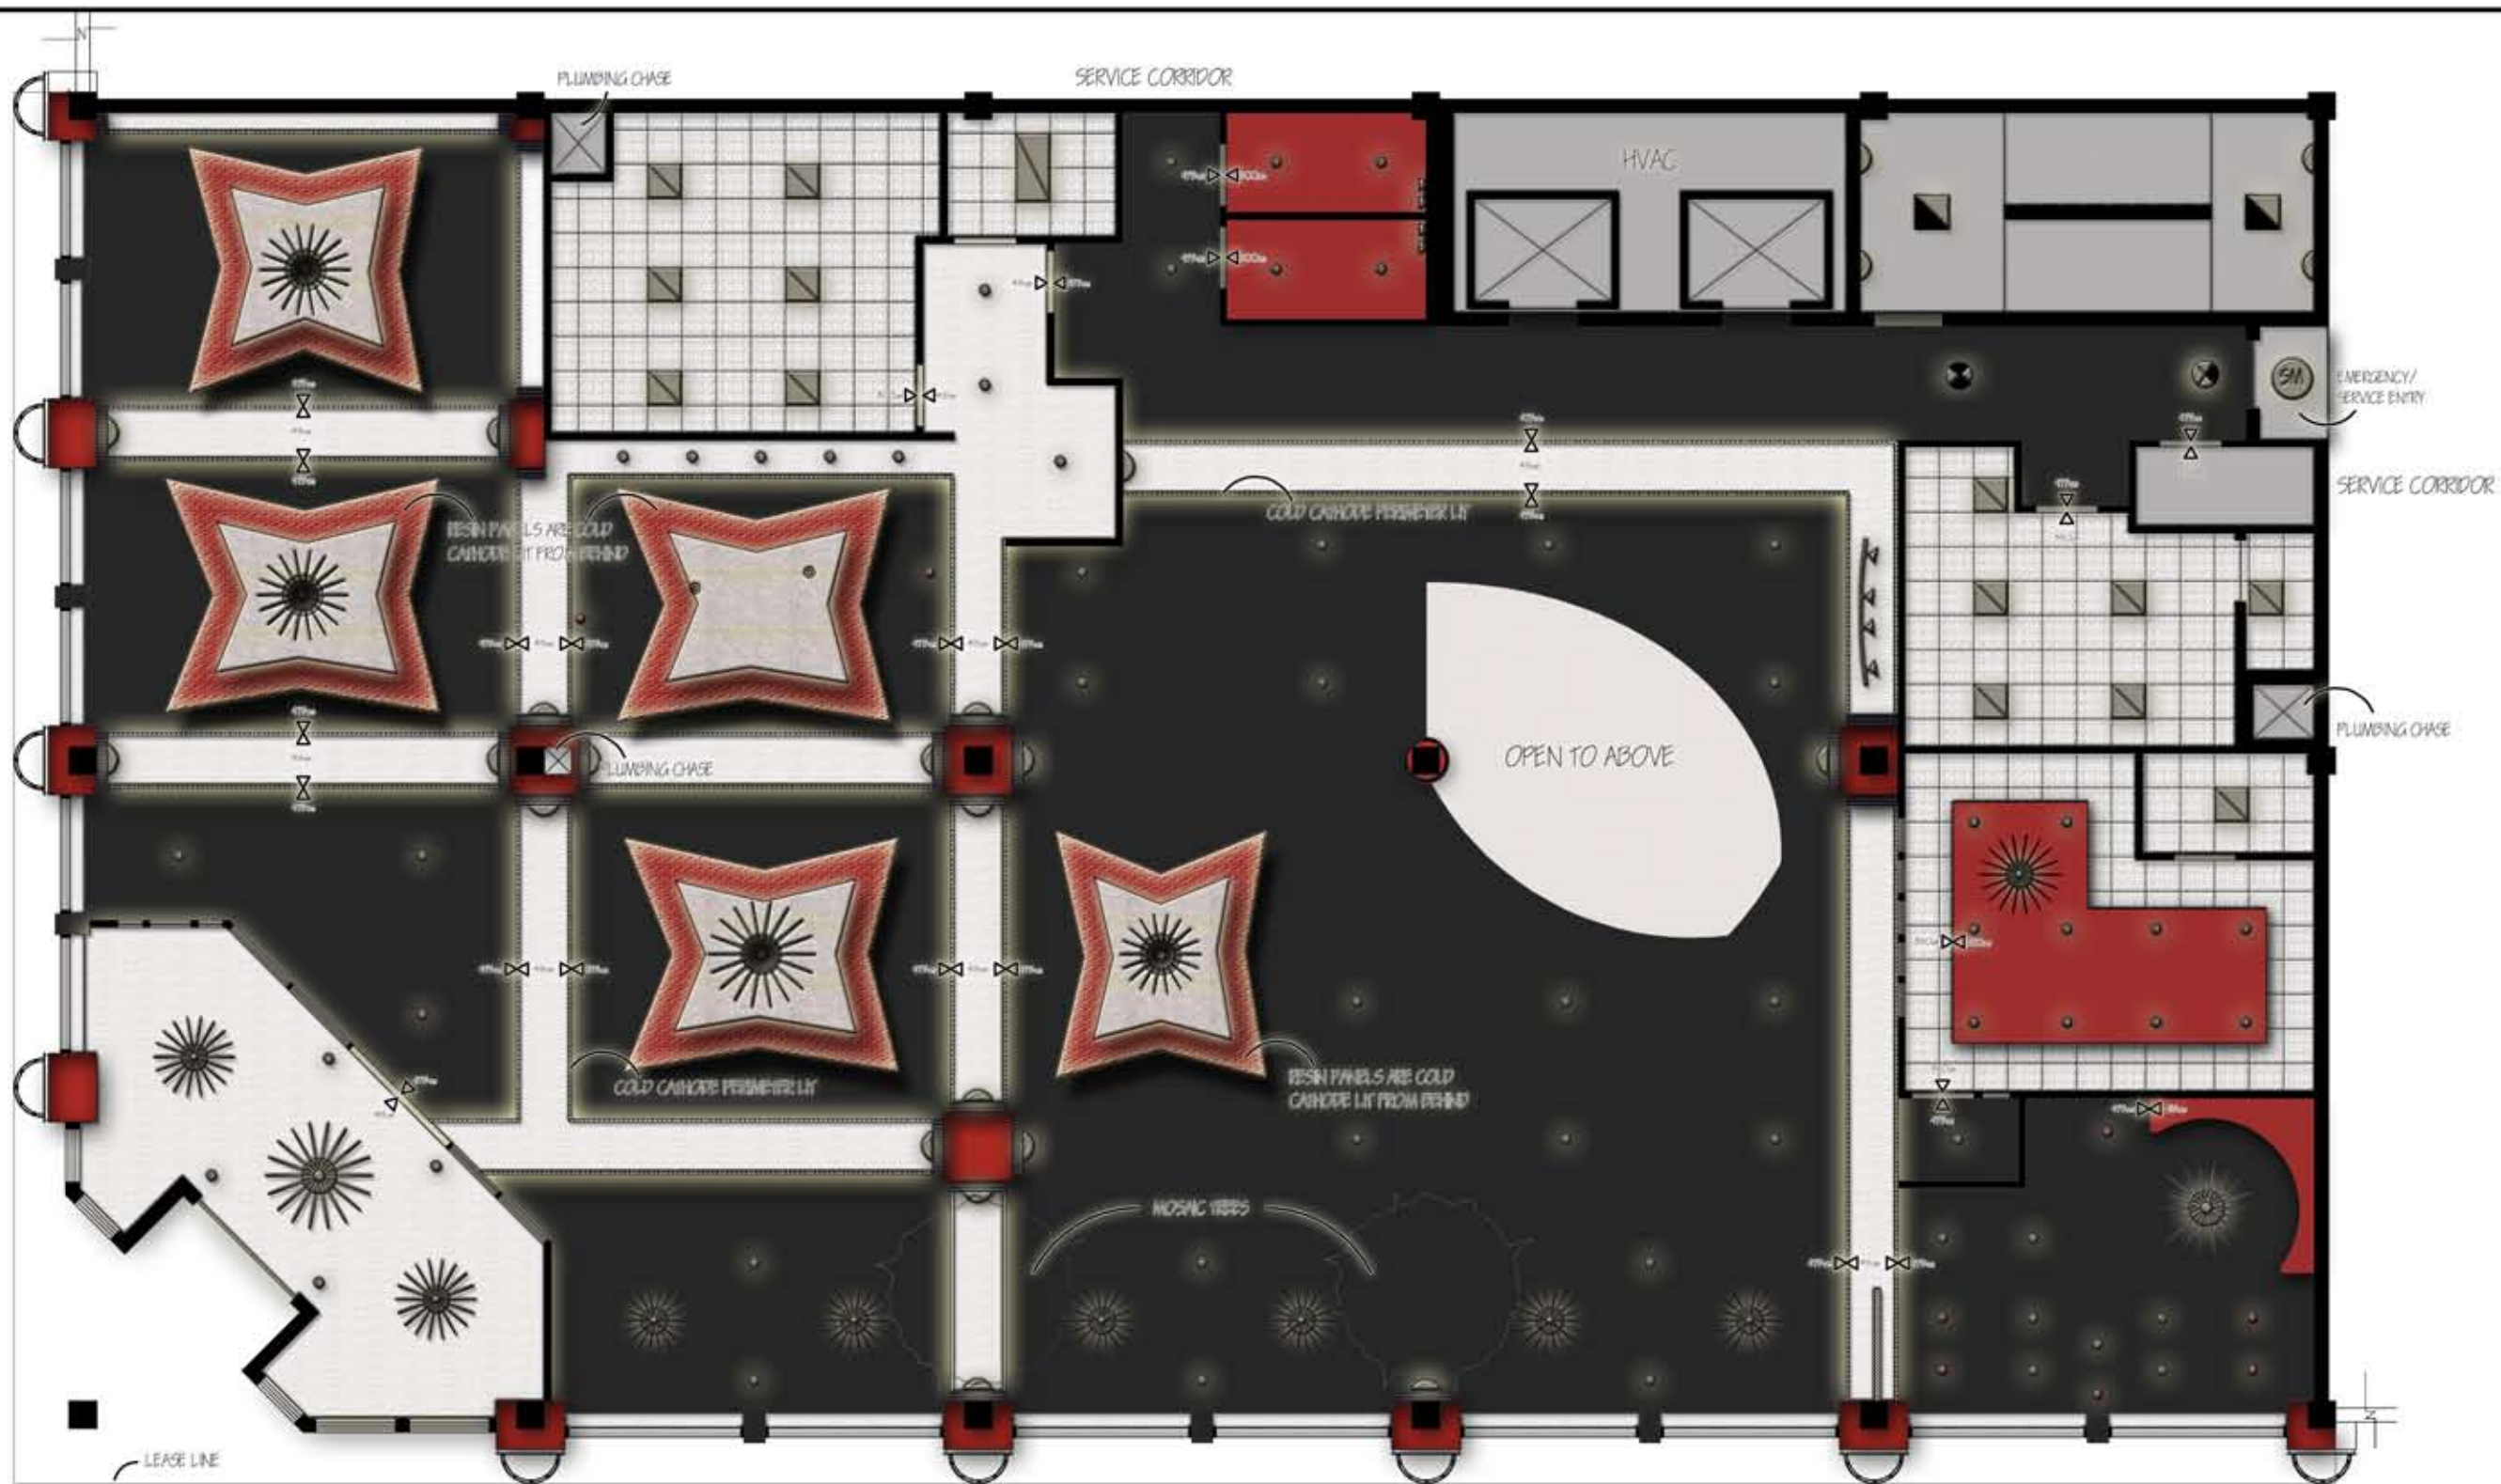


LIGHTING LEGEND:			
(R)	RECESSED LIGHTS	⚡	TRACK LIGHTING
(P)	HALOGEN PENDANT	☀	CHANDELIER
⬡	50 x 100 cm TROPHER	◻	50 x 50 cm TROPHER
⬢	VANITY LIGHT	⬢	BATTERY OPERATED EMERGENCY
⬢	EXIT LIGHTS	⬢	SCONCE
⬢		⬢	SURFACE MOUNTED
⬢		⬢	COLD CATHODE PERIMETER

ONYX



REFLECTED CEILING PLAN: FLOOR 1  
SCALE: 1:80 cm




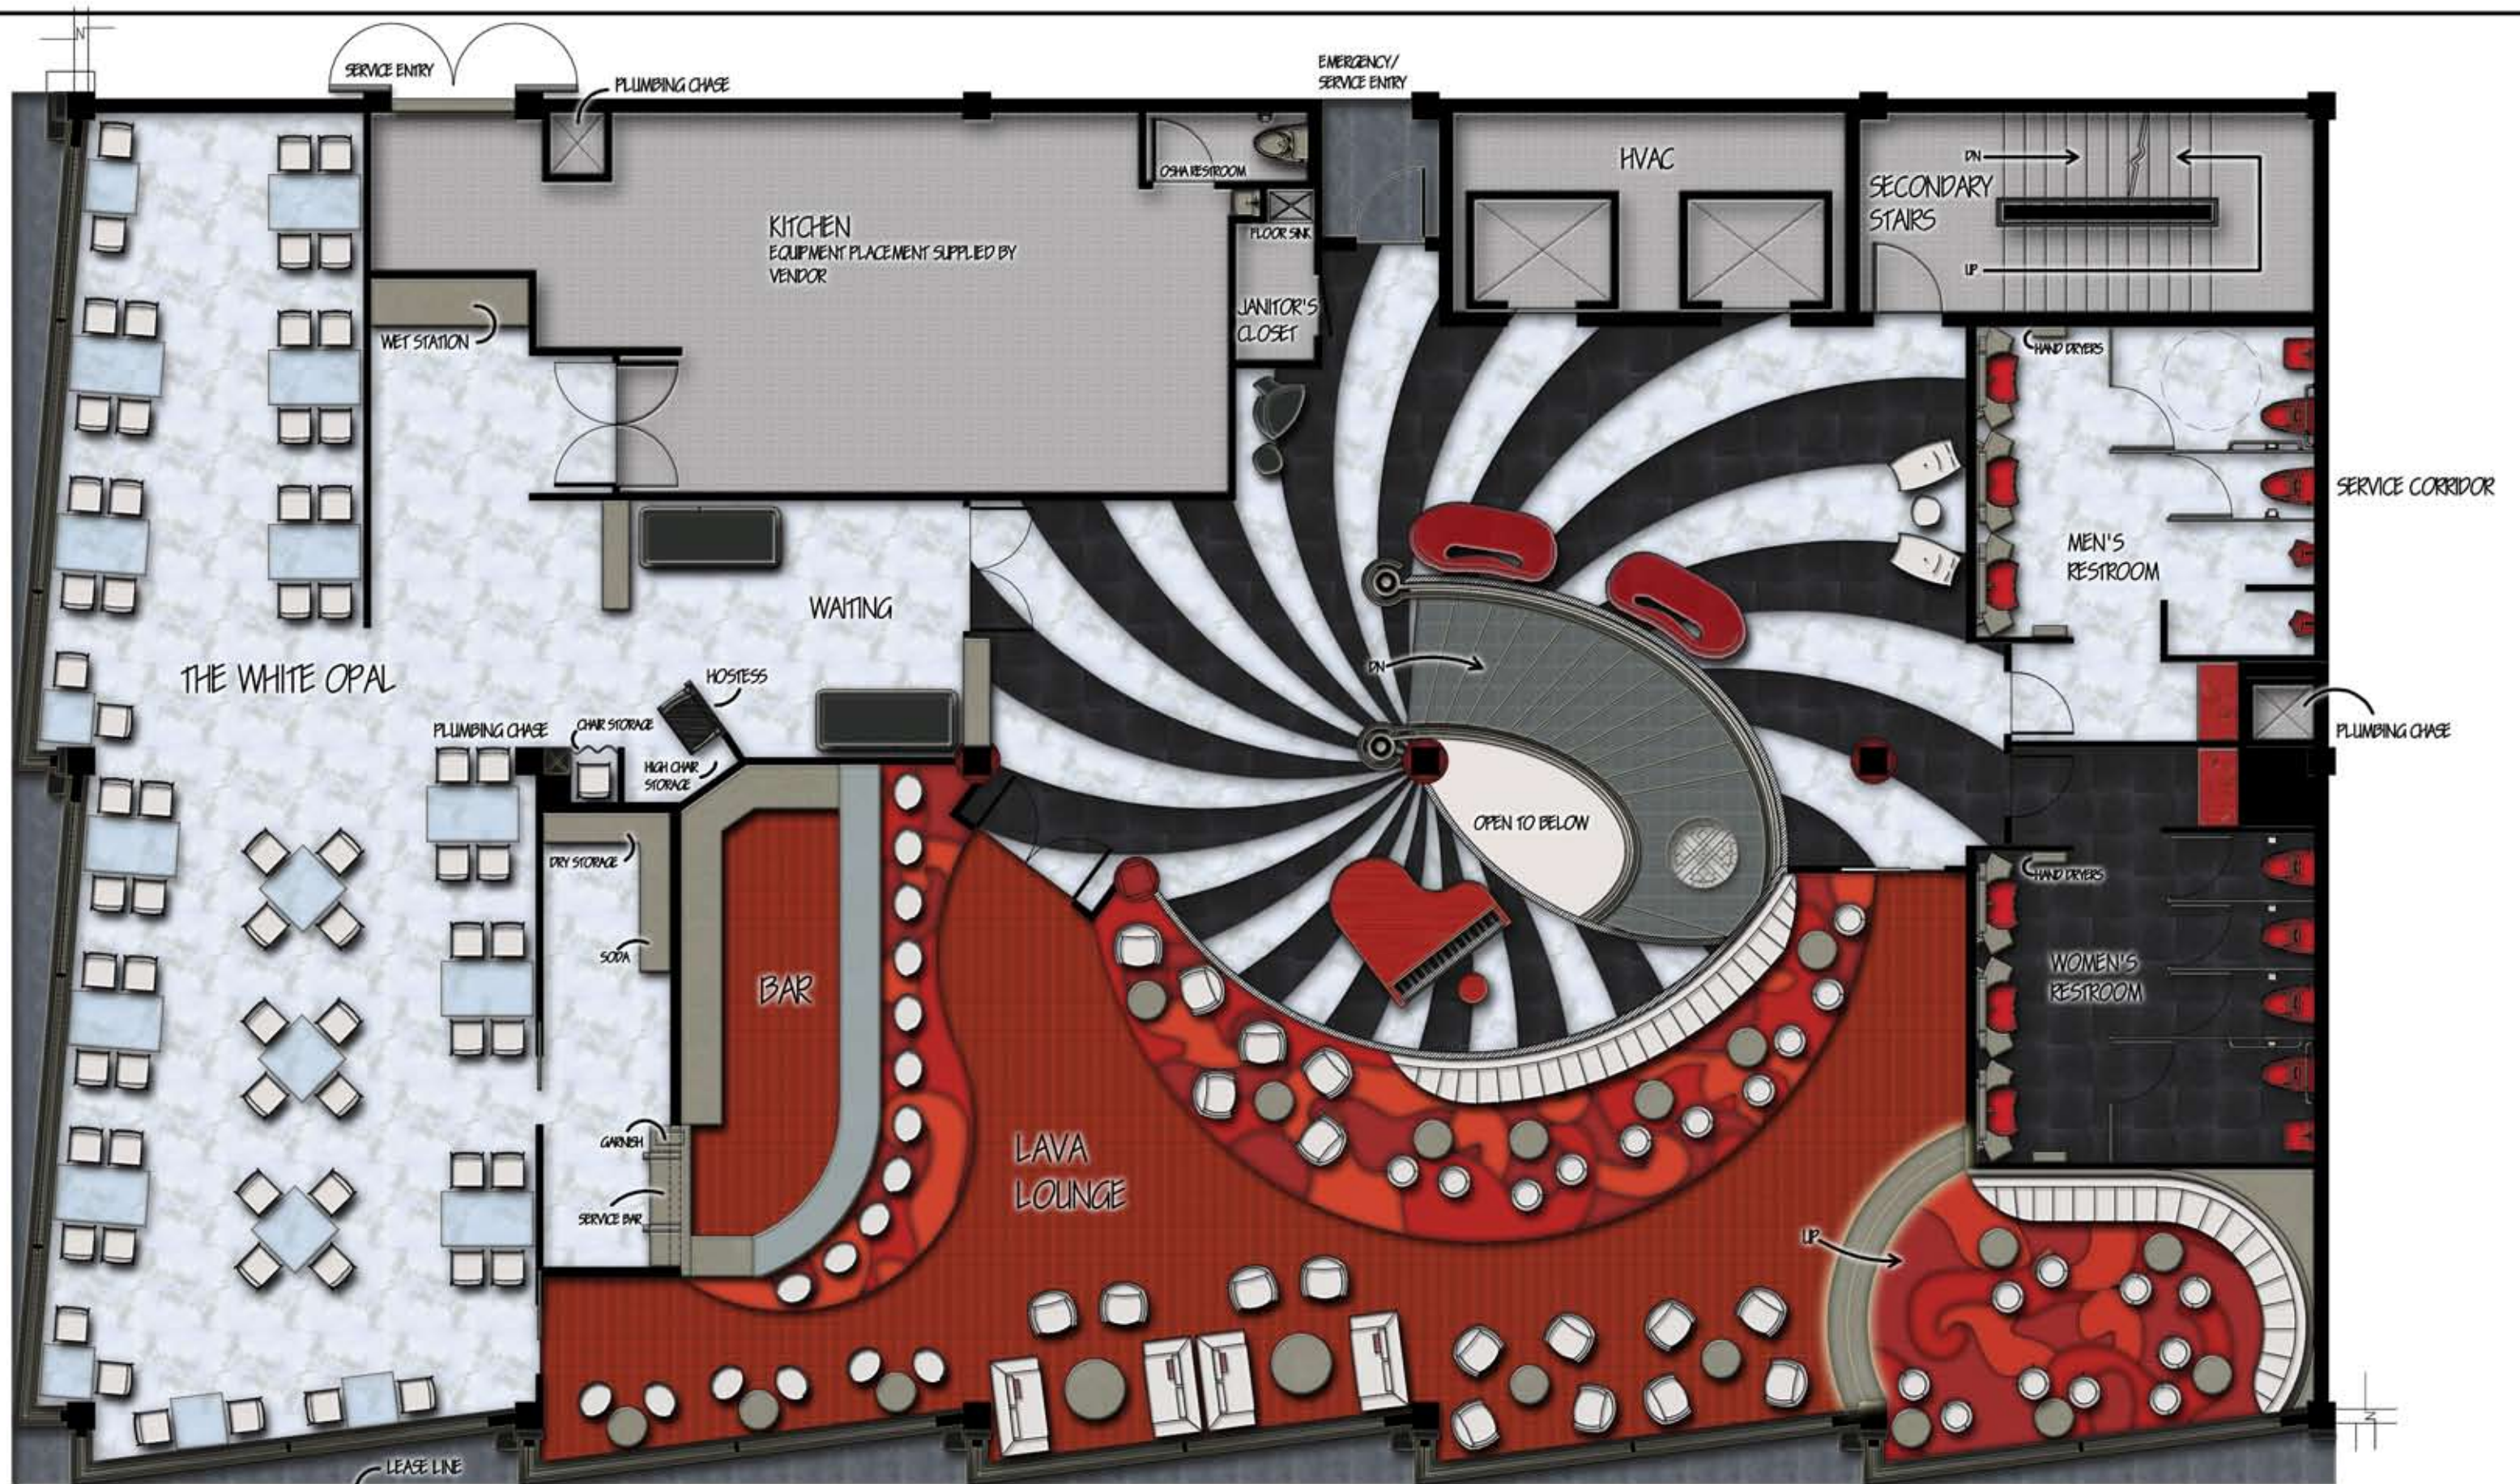

ONYX

FLOOR PLAN 2  
SCALE: 1:80 cm



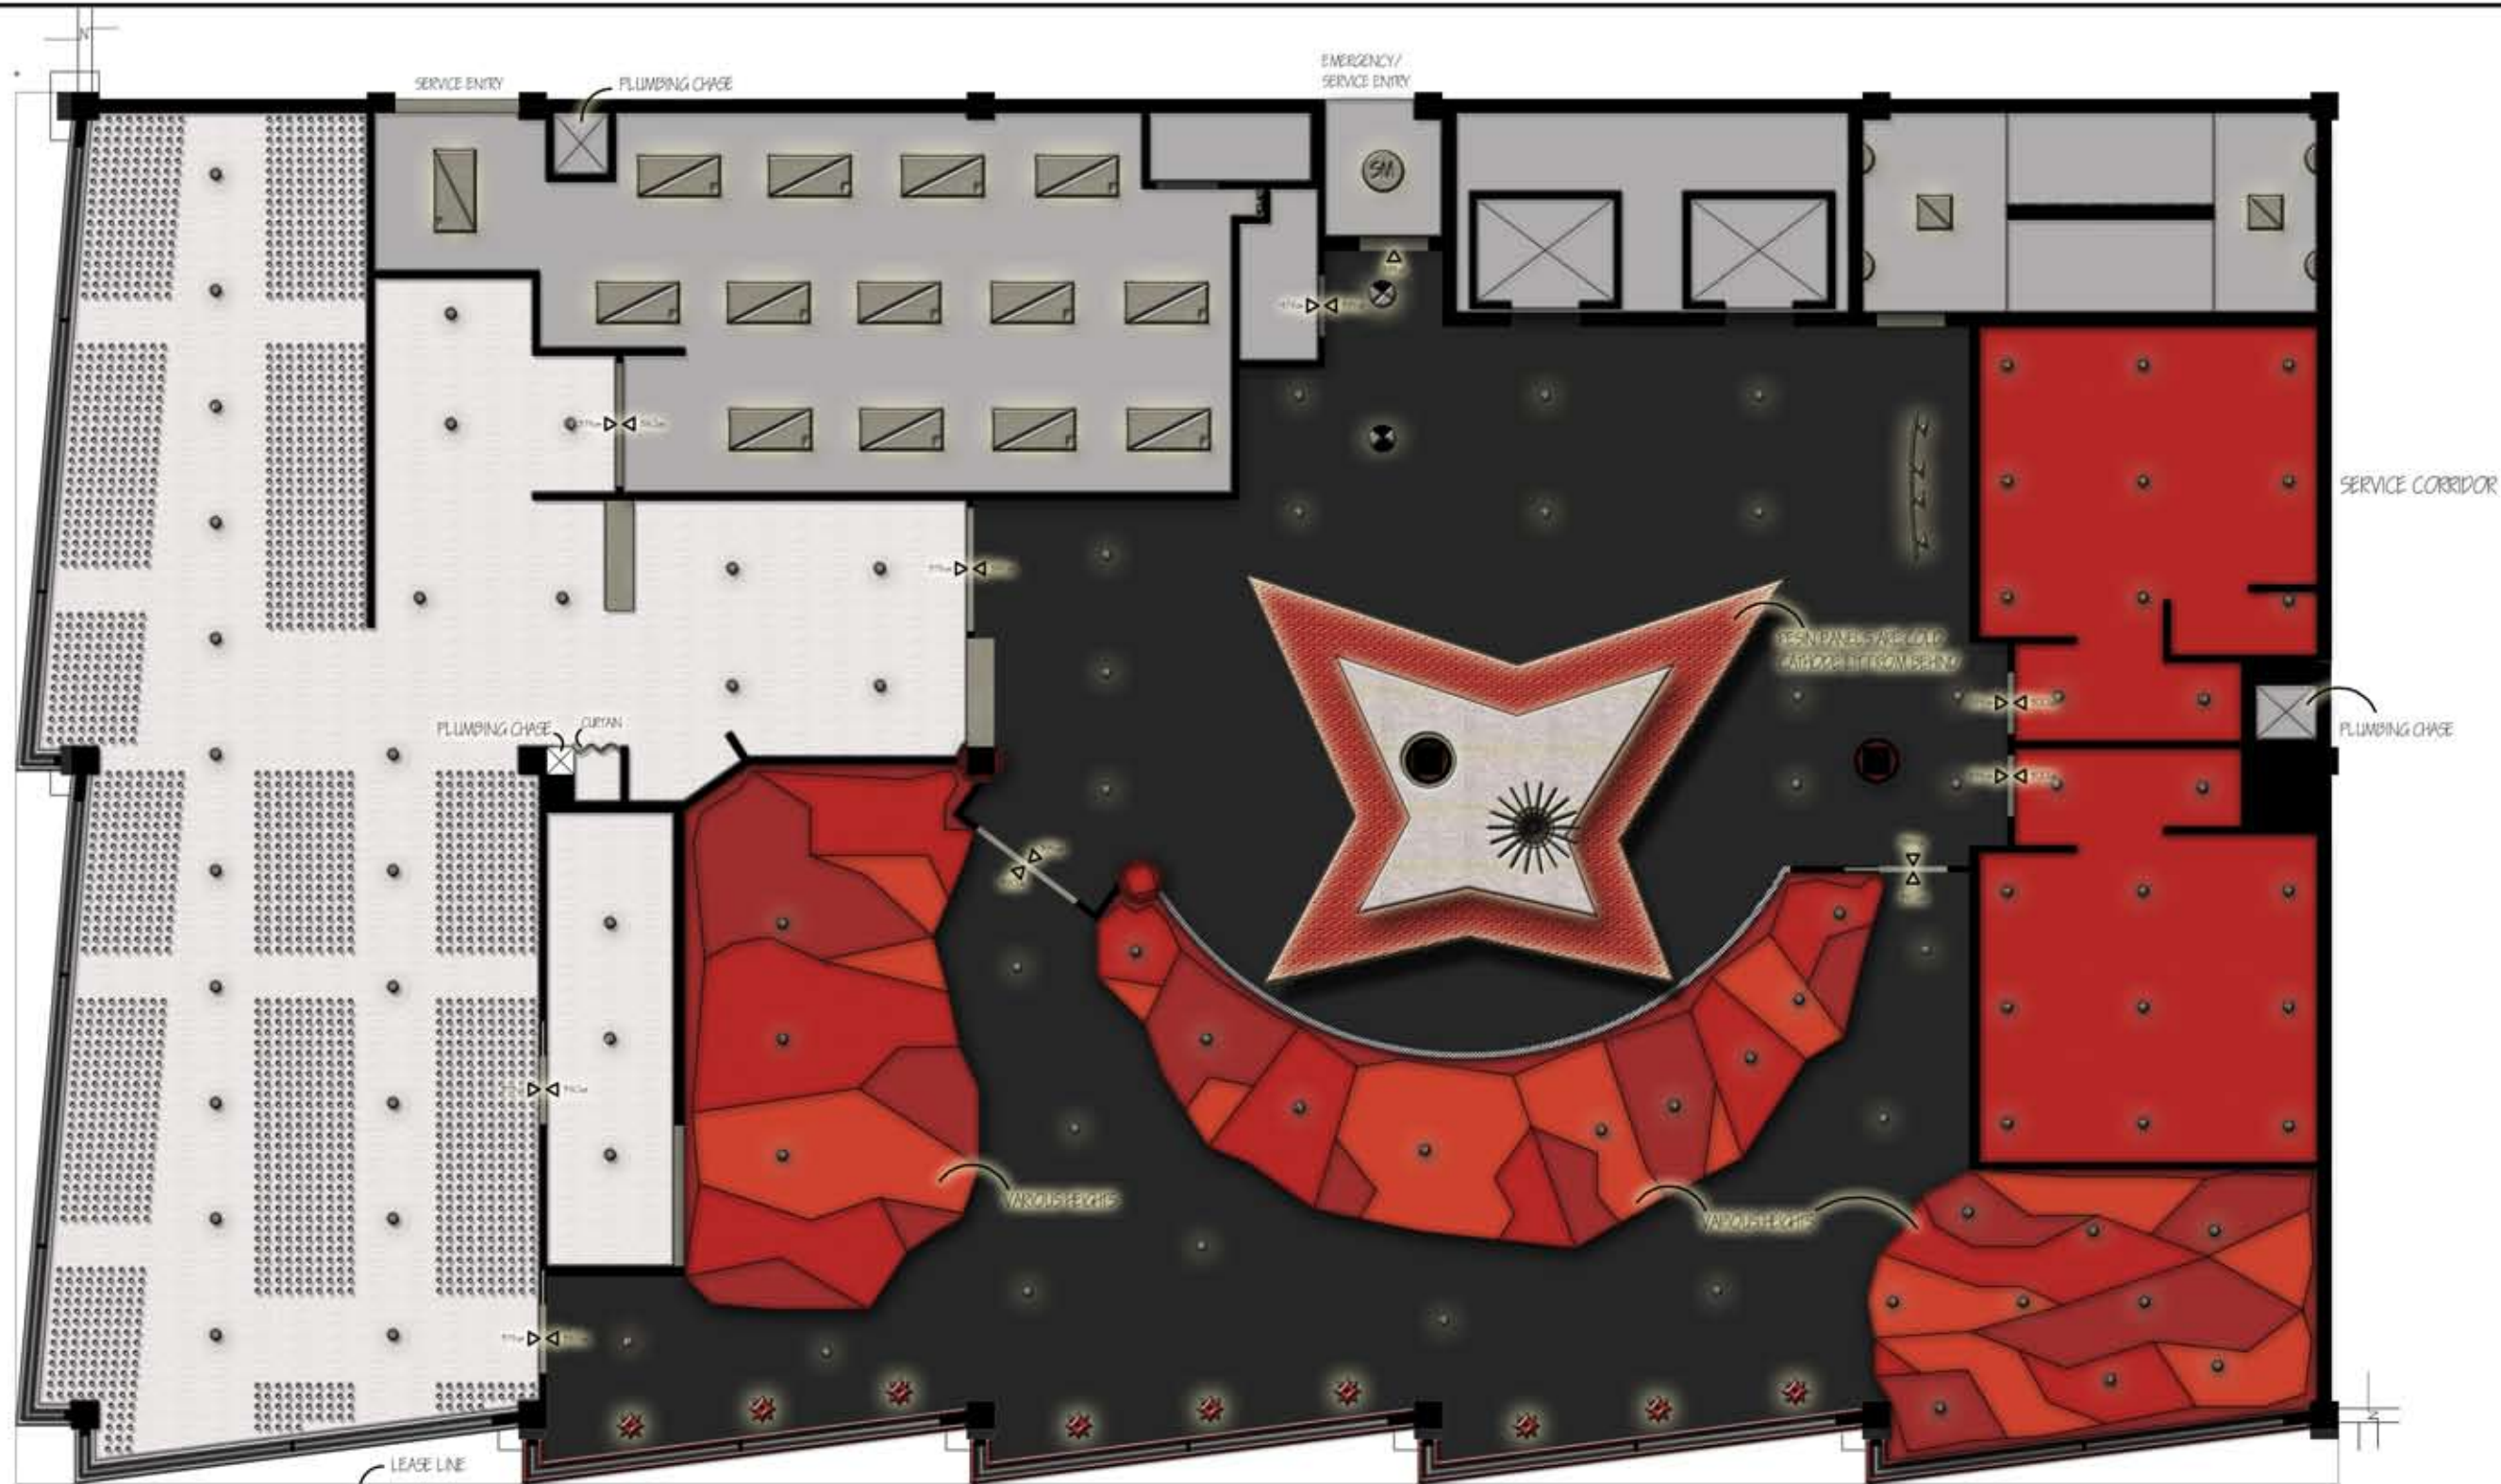

LIGHTING LEGEND:

(R)	RECESSED LIGHTS		TRACK LIGHTING		VANITY LIGHT	(SM)	SURFACE MOUNTED
	INCANDESCENT PENDANT		CHANDELIER		BATTERY OPERATED EMERGENCY		
	SUSPENDED PENDANT LIGHTS		FIBEROPTICS		EXIT LIGHTS		


ONYX






REFLECTED CEILING PLAN: FLOOR 2  
SCALE: 1:80 cm





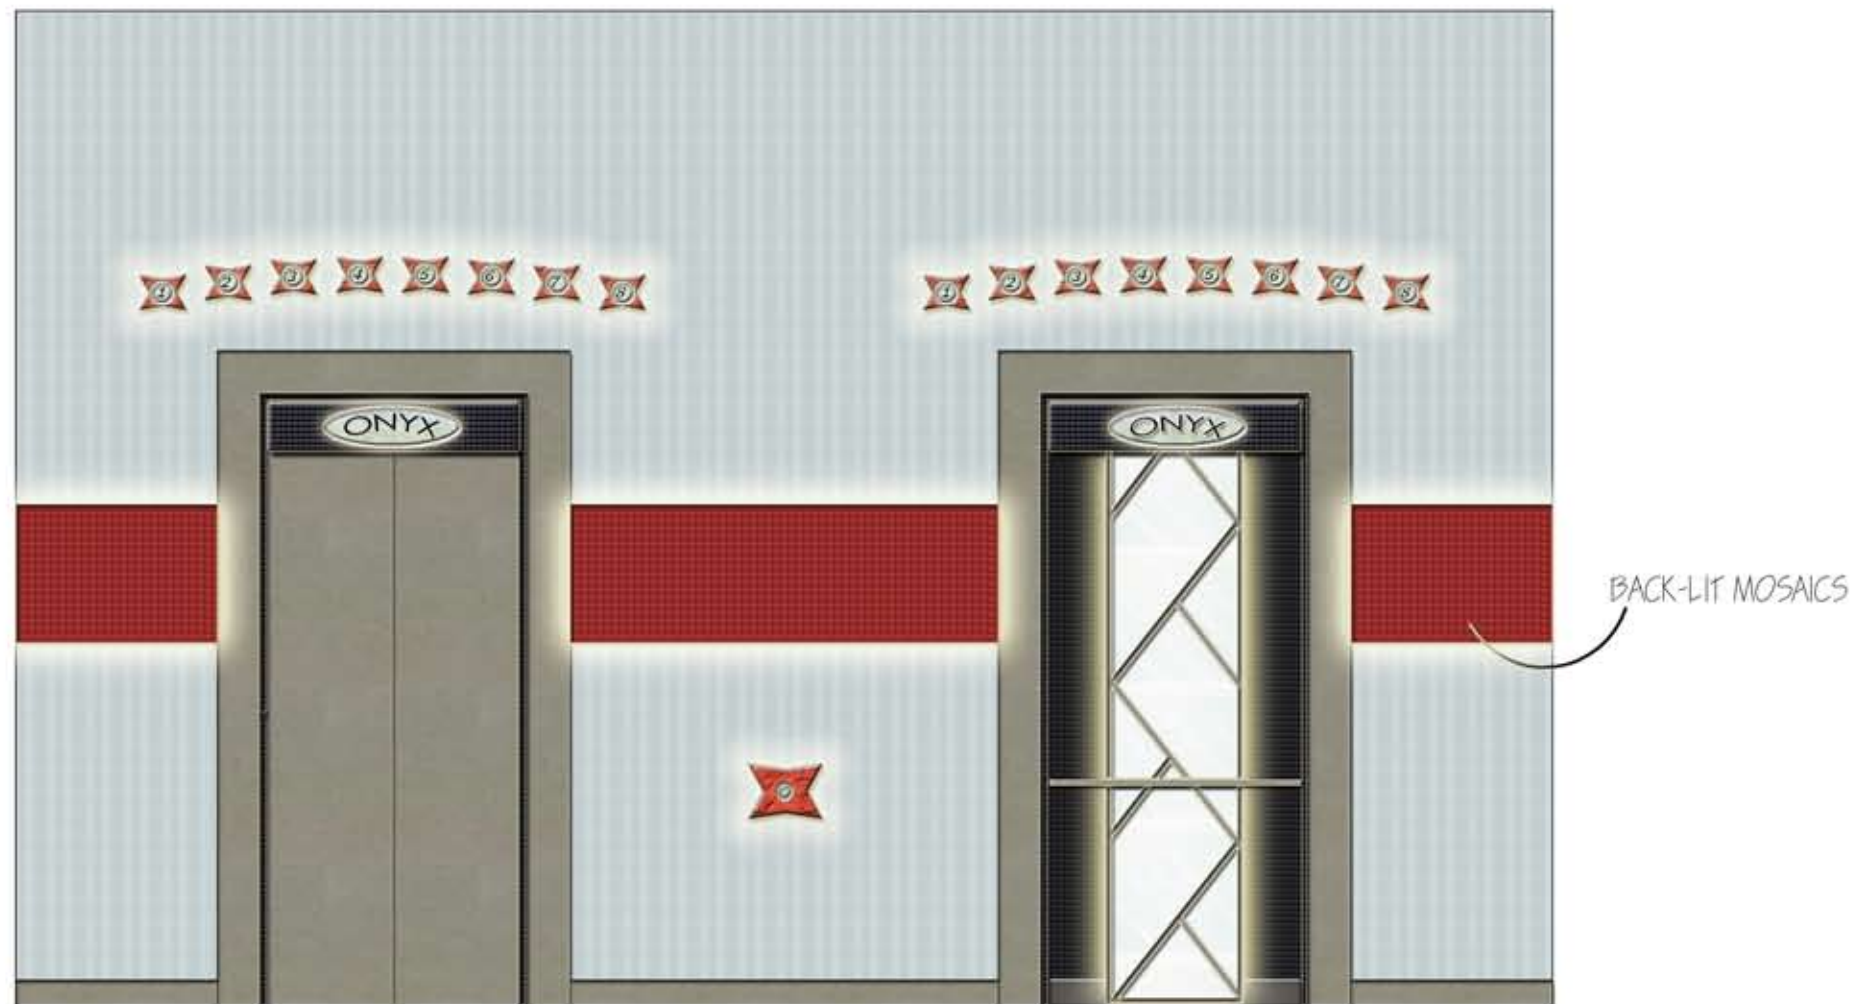

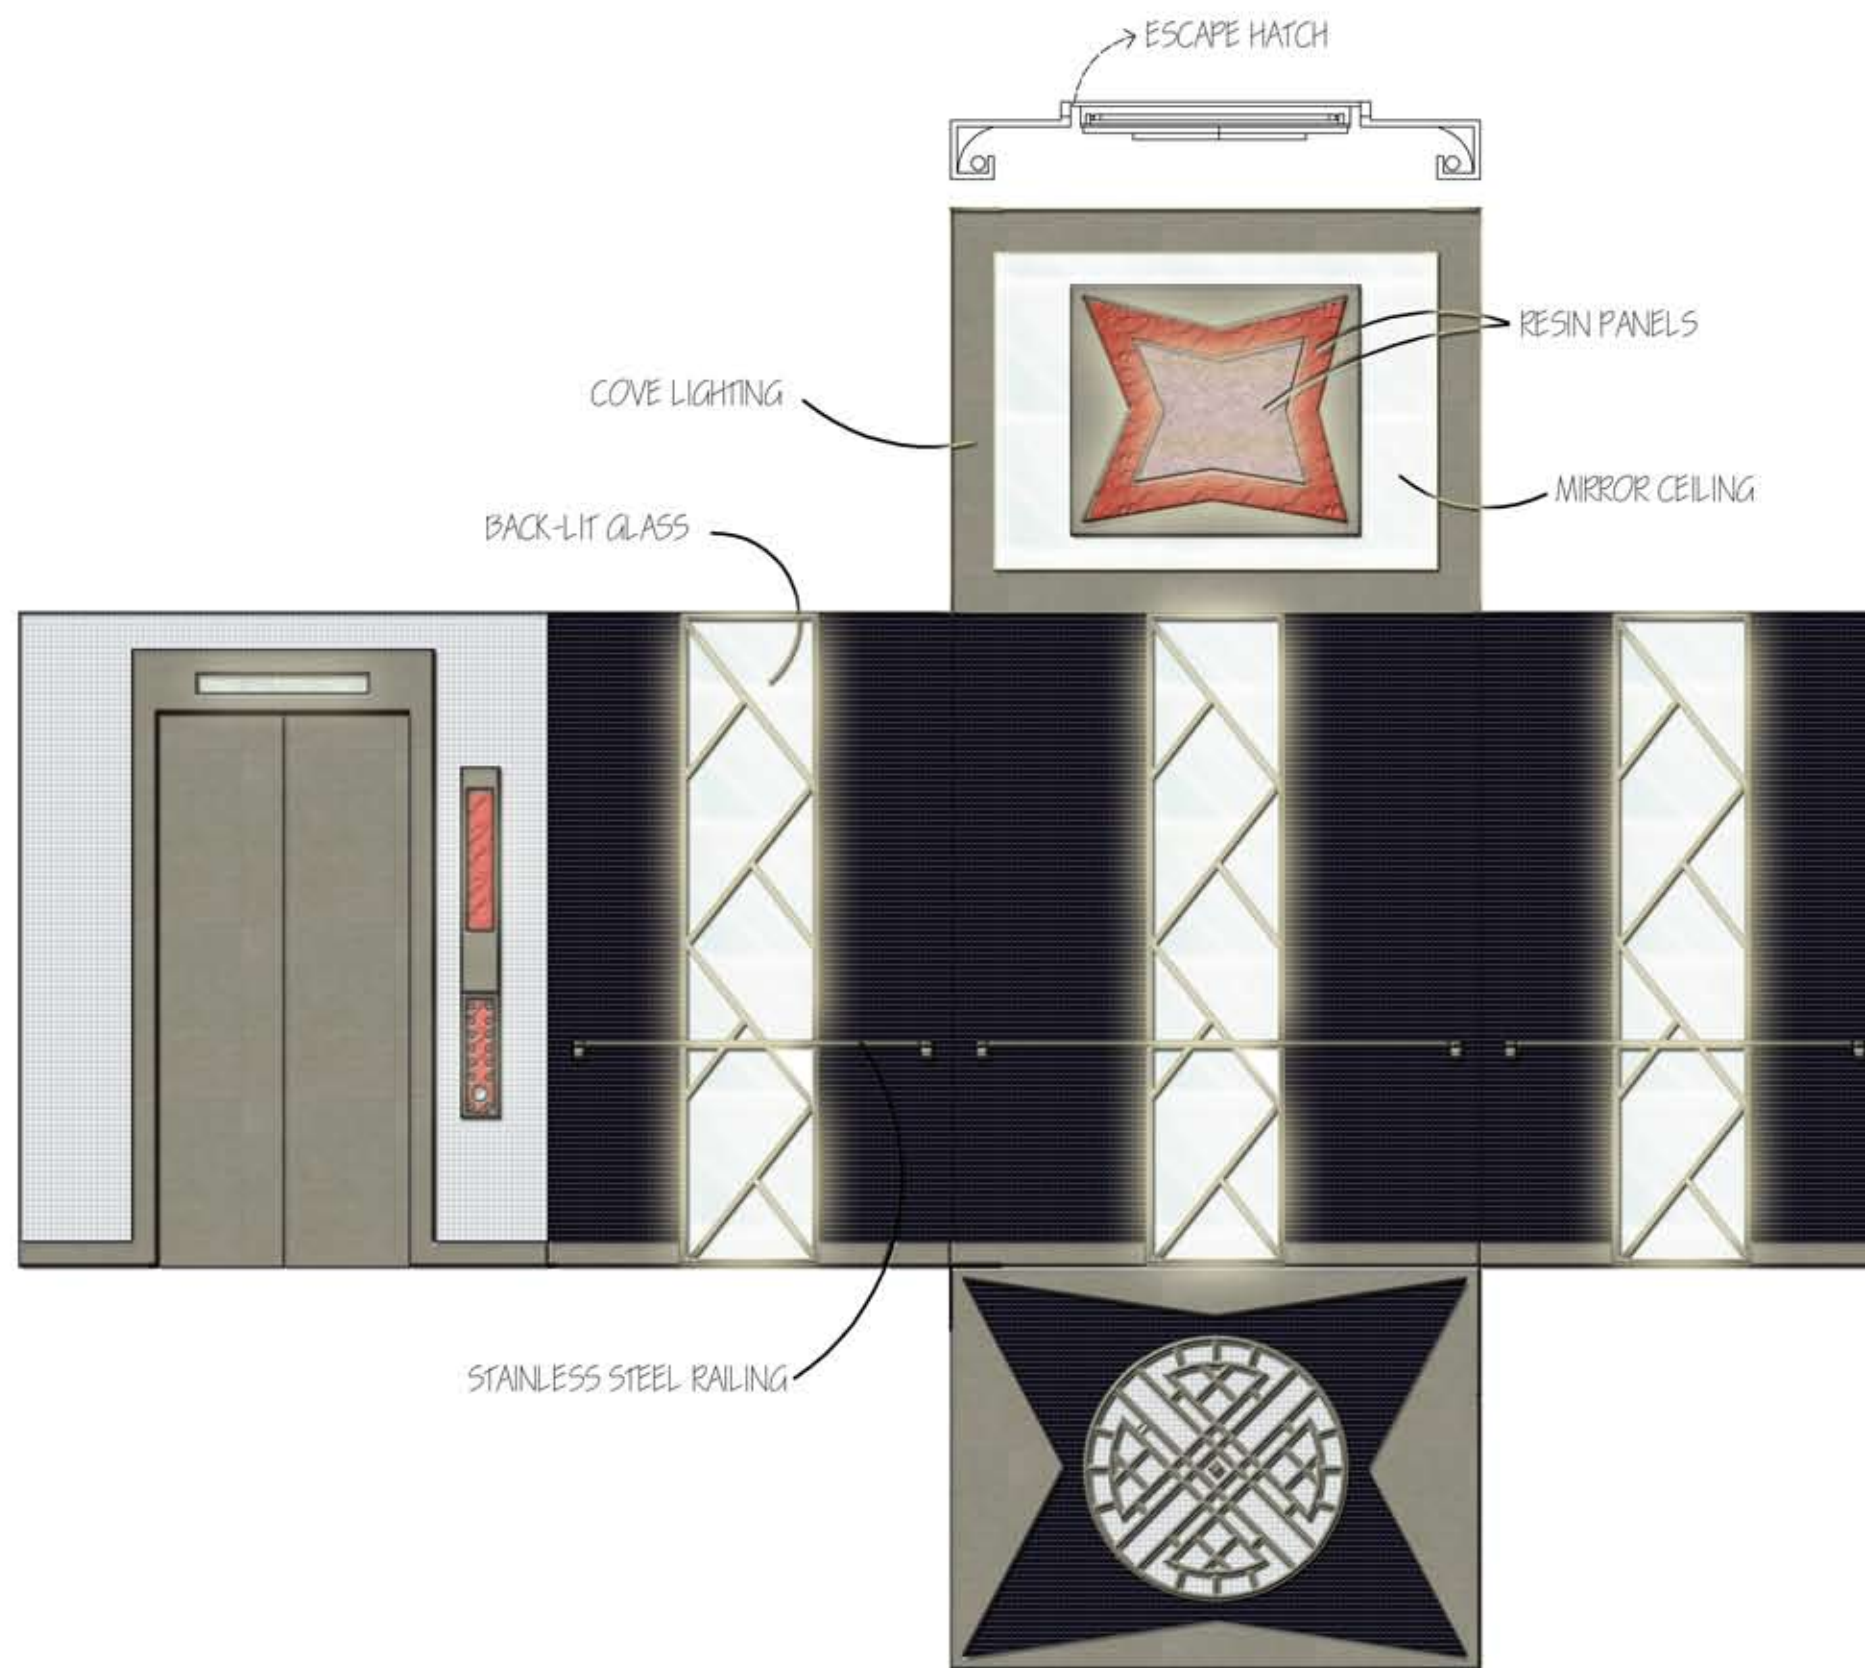

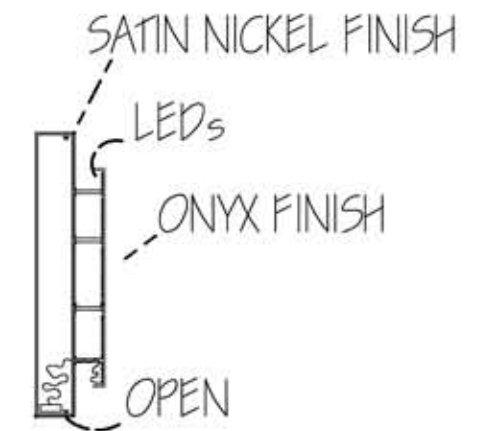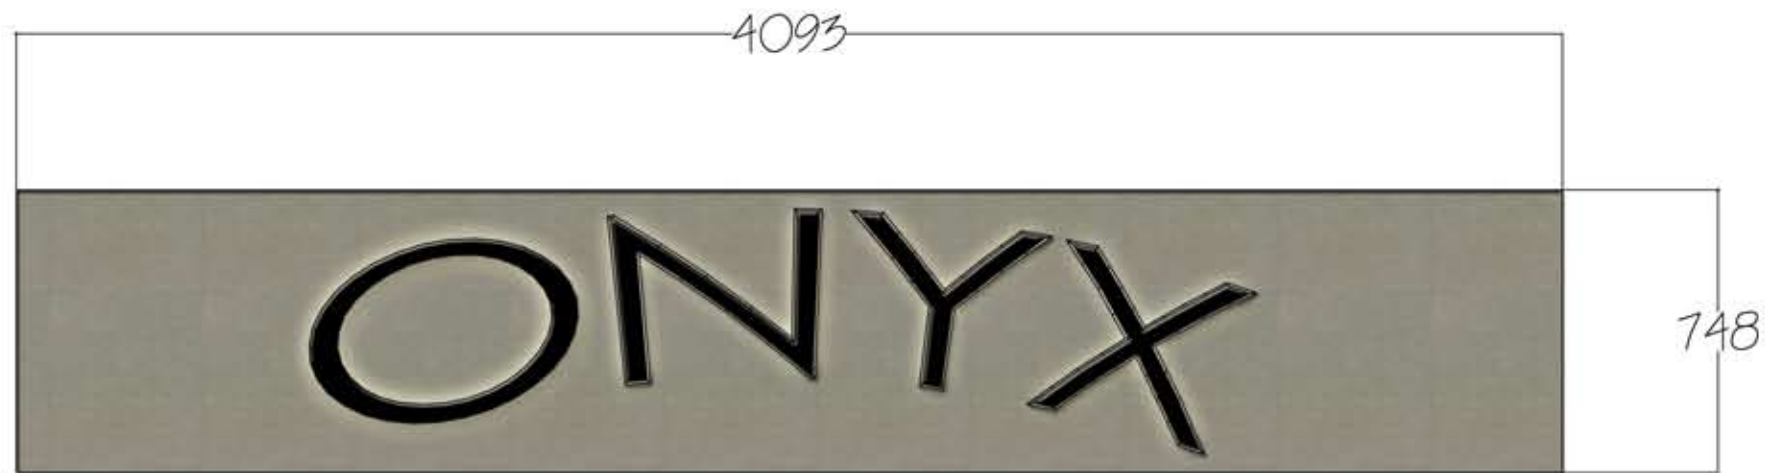























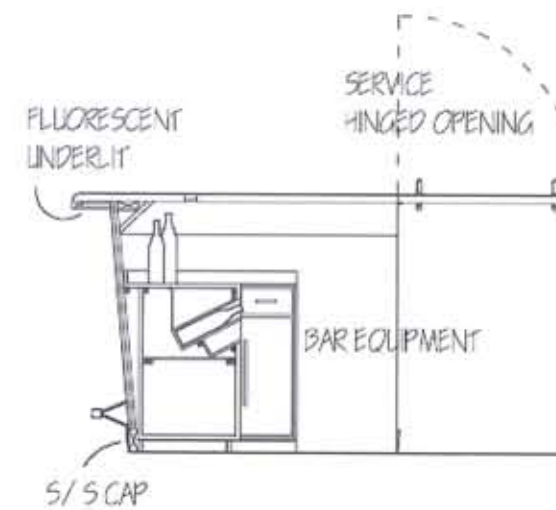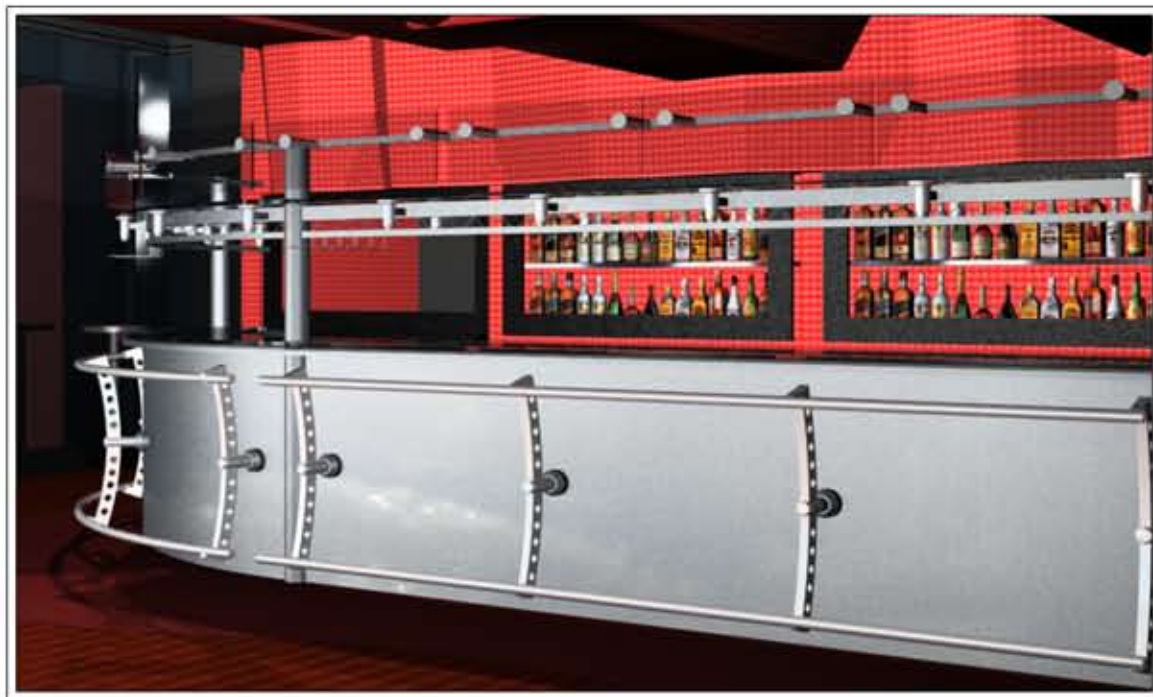



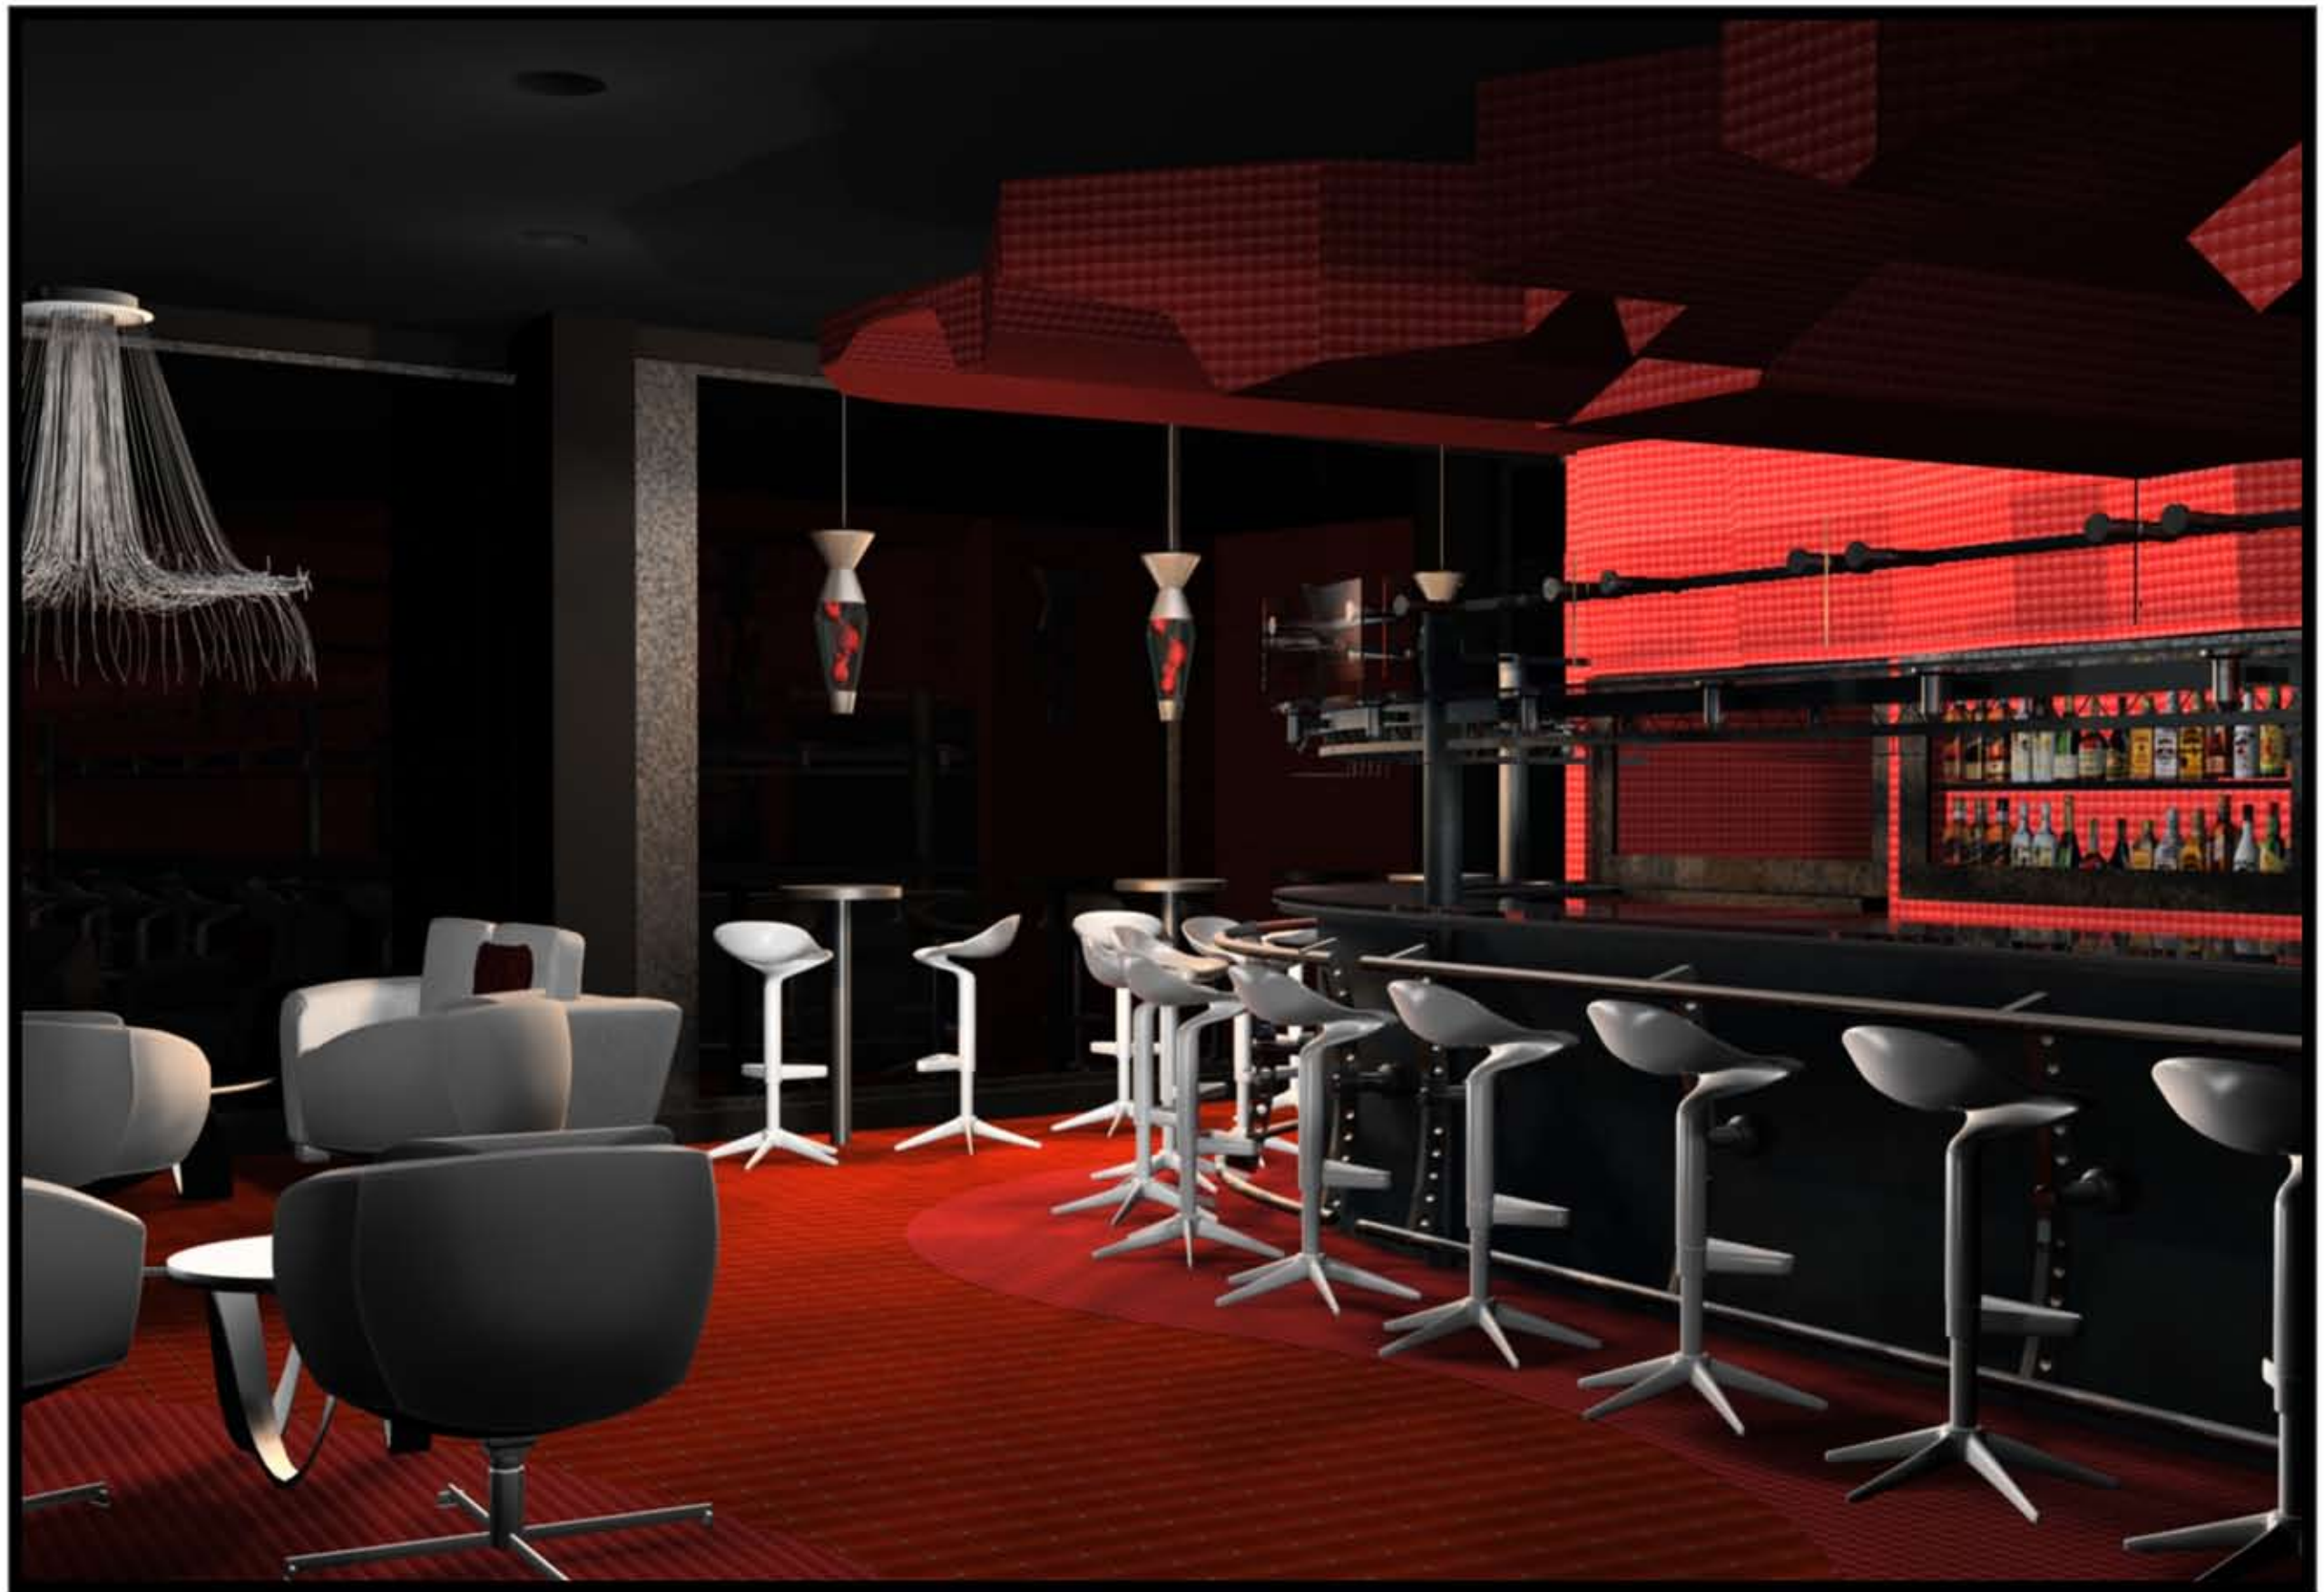




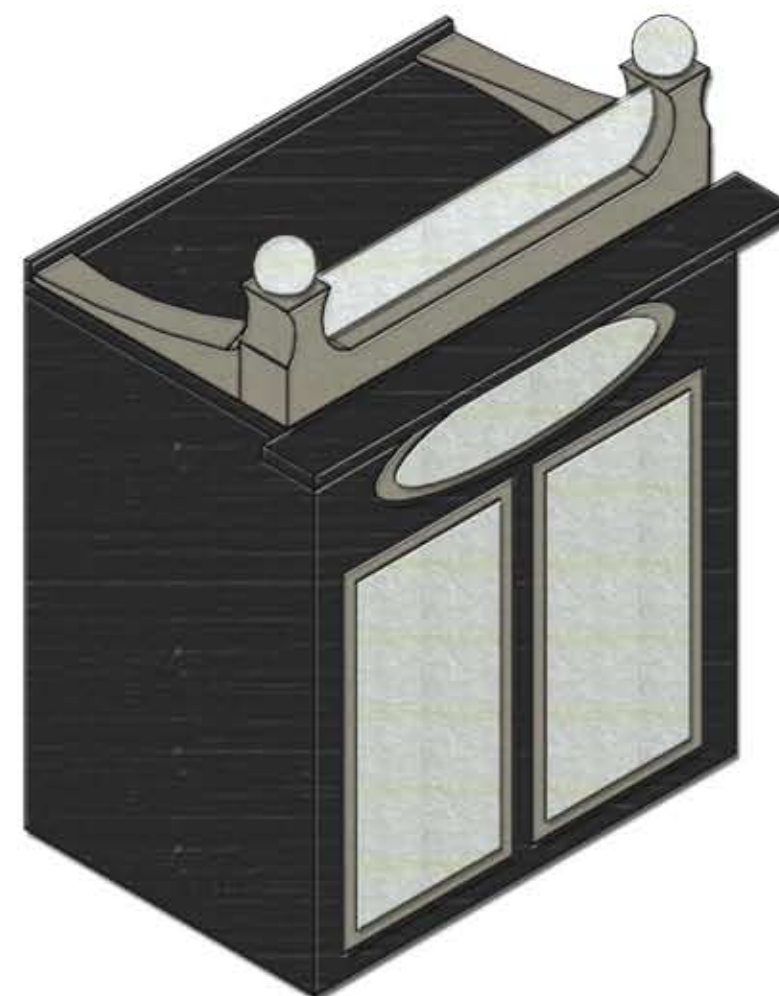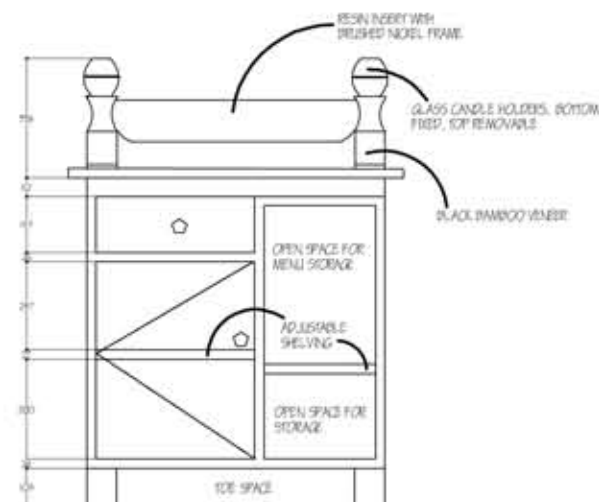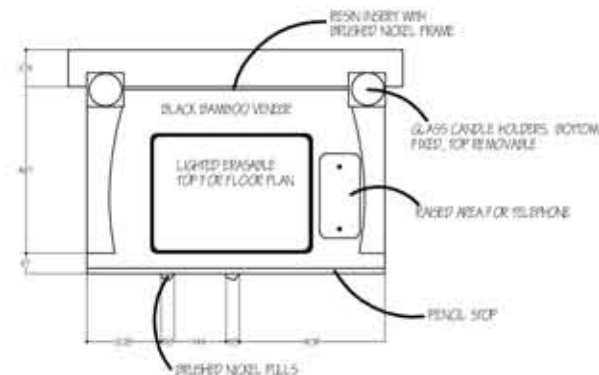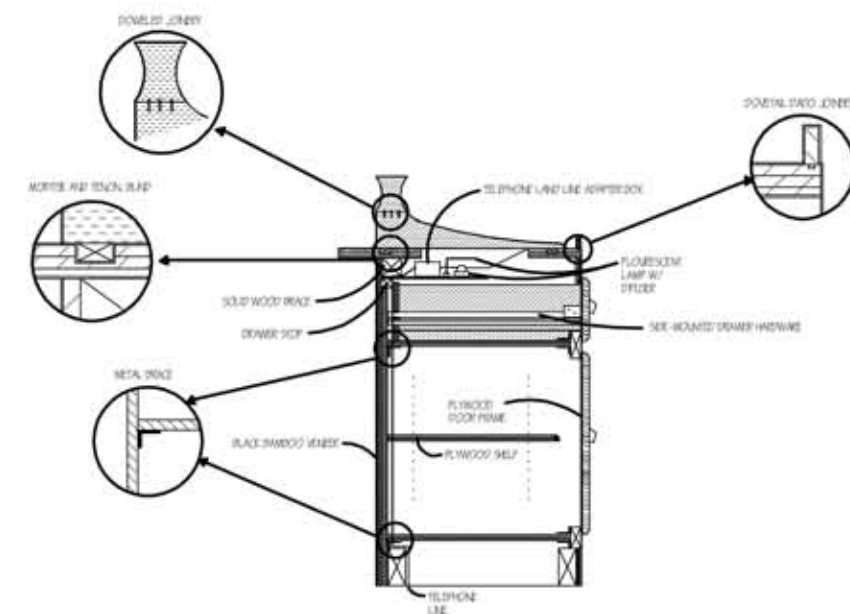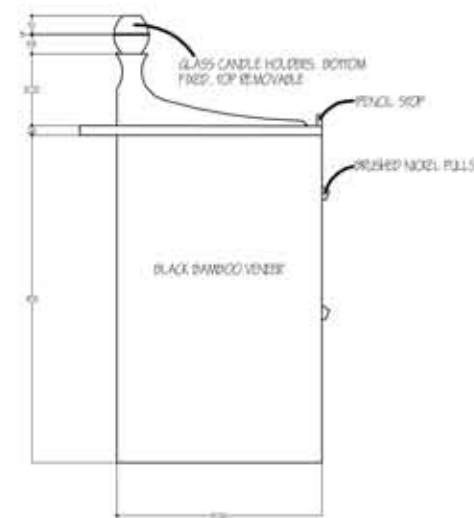





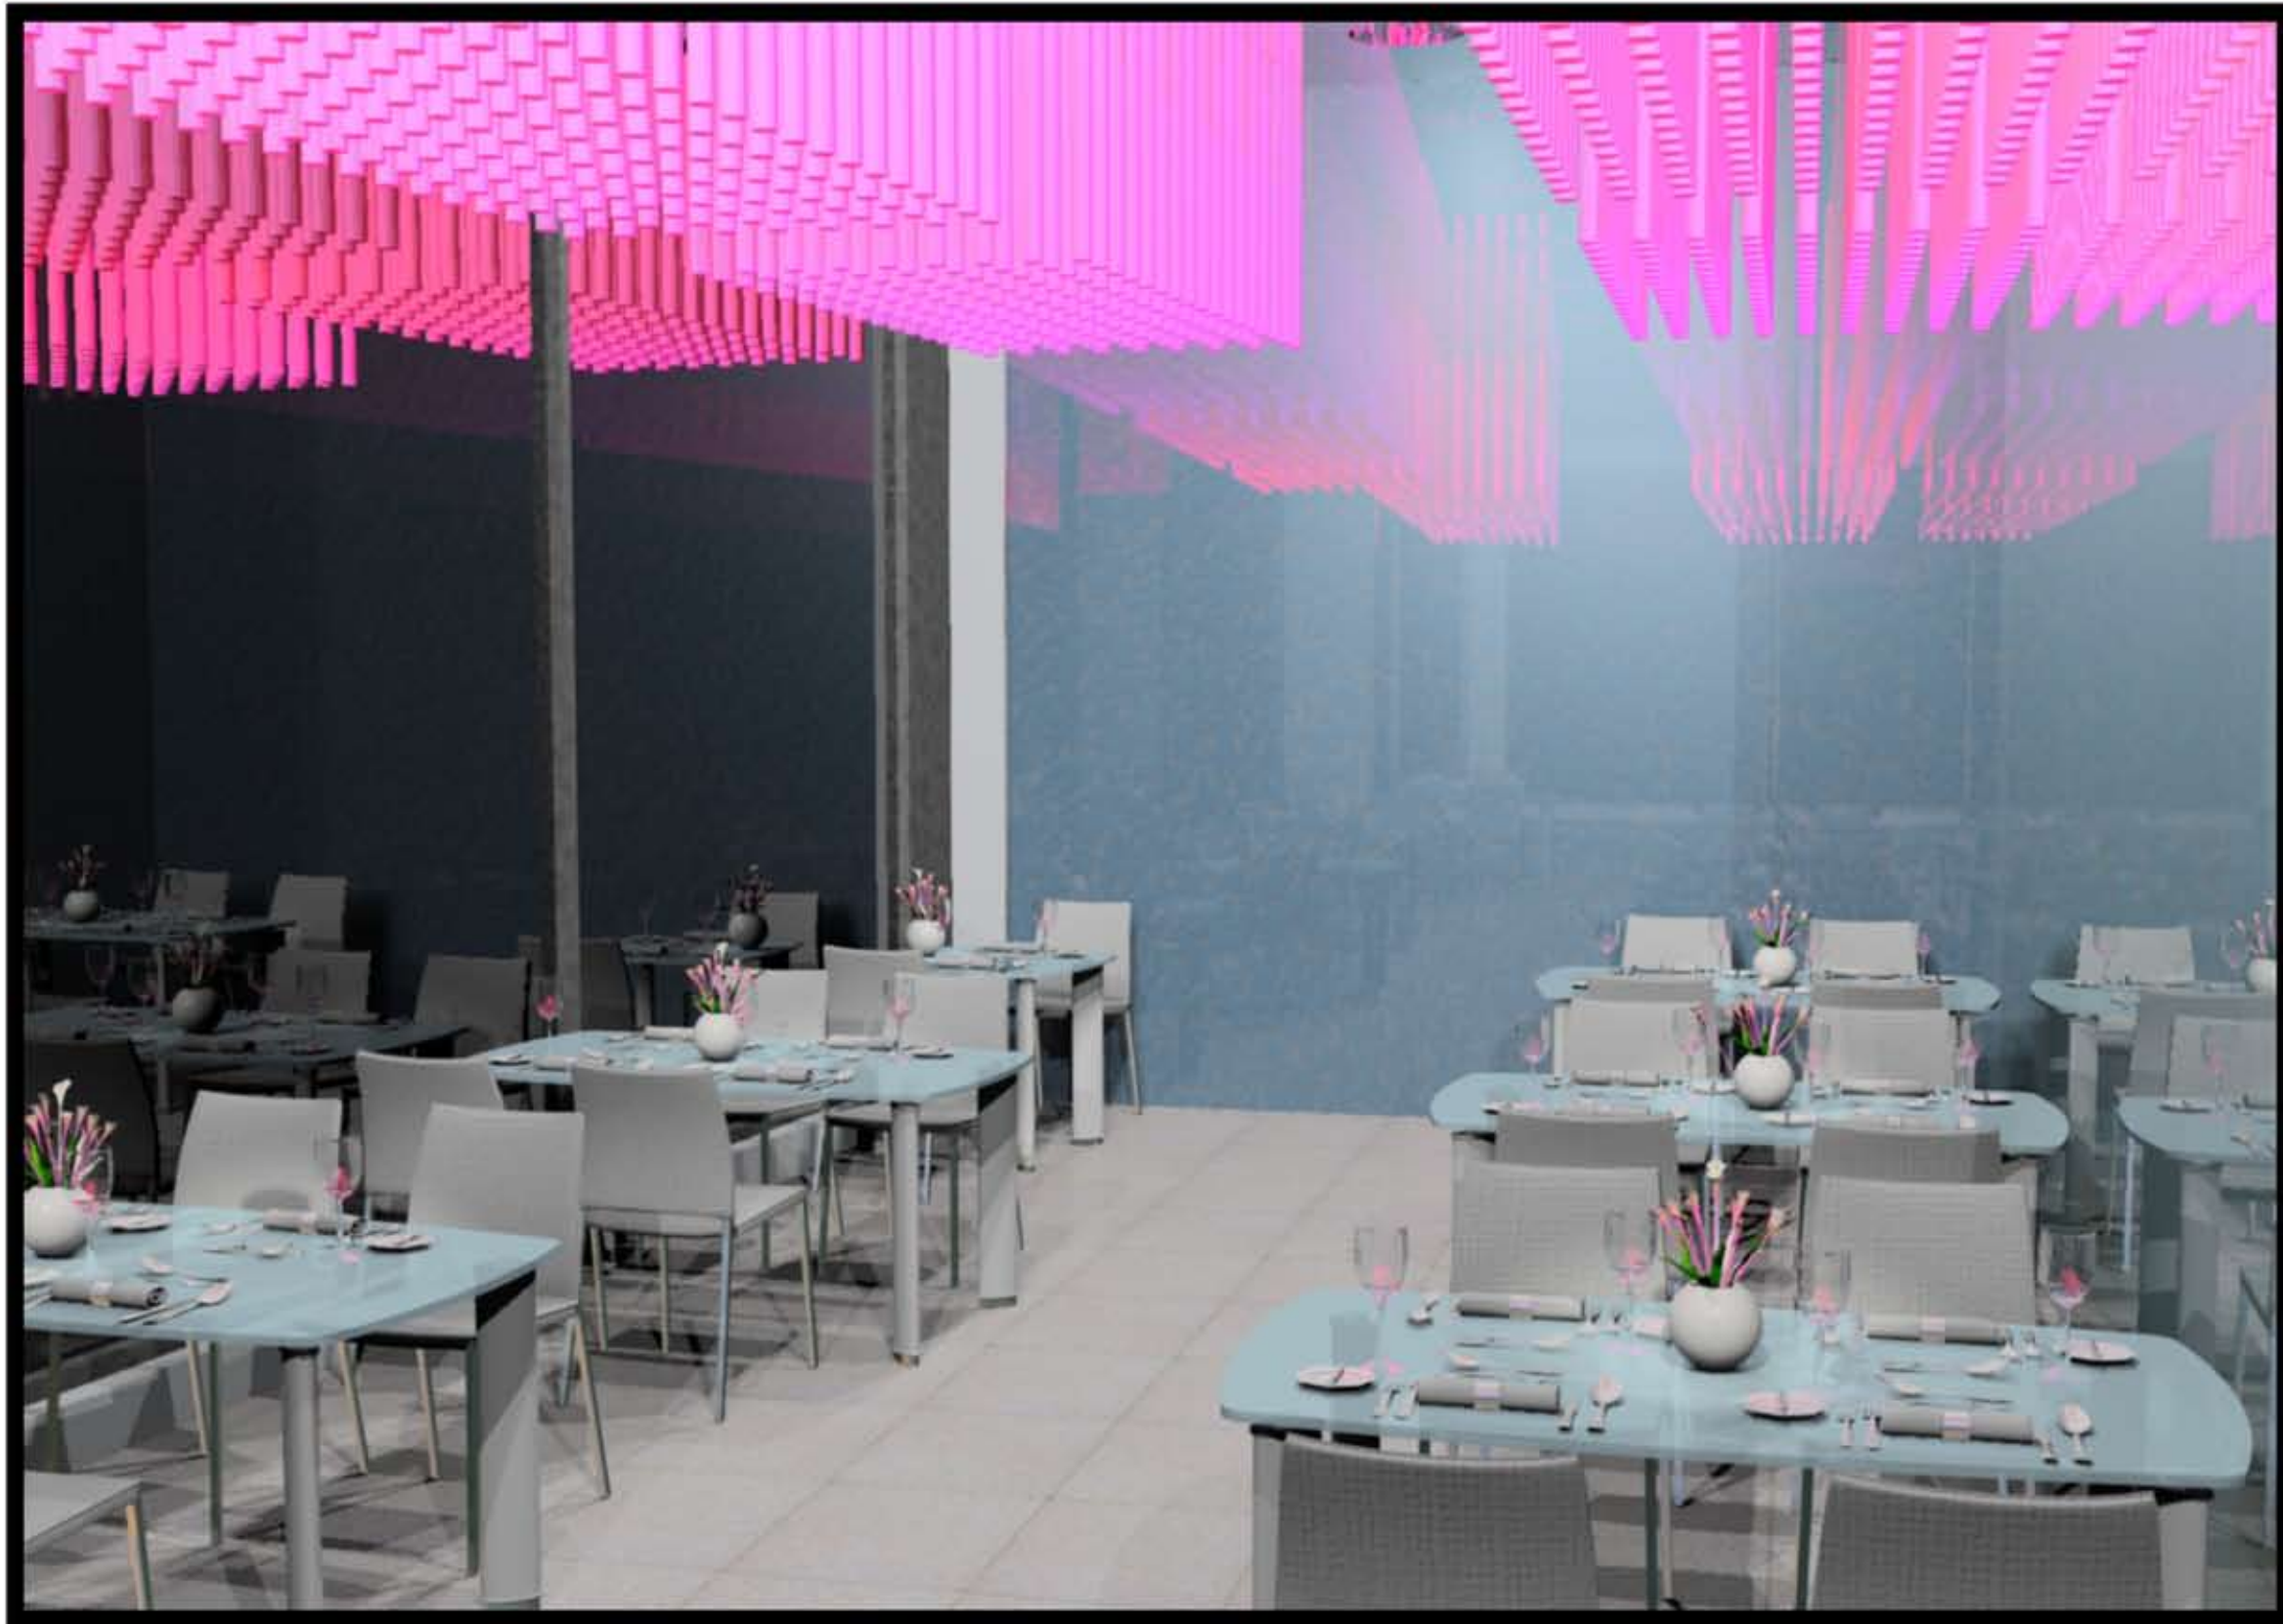

THE WHITE OPAL, PERSPECTIVE 2  
HOTEL PROJECT